


JOINT MUNICIPAL/LIBRARY BUILDING

C.T.H. "NN", EAGLE, WI

VILLAGE OF EAGLE
TOWN OF EAGLE

INDEX TO DRAWINGS

- G001 - SITE PLAN
- A101 - FLOOR PLAN
- A102 - ALTERNATE FLOOR PLAN
- A201 - ELEVATIONS
- A202 - SECTIONS AND DETAILS
- A401 - REFLECTED CEILING PLANS
- A601 - ROOM FINISH SCHEDULE
- A602 - DETAILS
- A603 - DETAILS
- S101 - FOUNDATION PLAN AND DETAILS
- S201 - ROOF FRAMING PLANS
- S401 - STRUCTURAL DETAILS
- P101 - PLUMBING FLOOR PLAN
- P201 - SCHEMATICS AND DETAILS
- H101 - HVAC FLOOR PLAN
- H201 - SCHEDULES AND DETAILS
- E101 - ELECTRICAL SITE PLAN
- E102 - ELECTRICAL PLAN LIGHTING
- E103 - ELECTRICAL PLAN POWER
- E104 - DETAILS
- E105 - ONE LINE, SCHEDULES

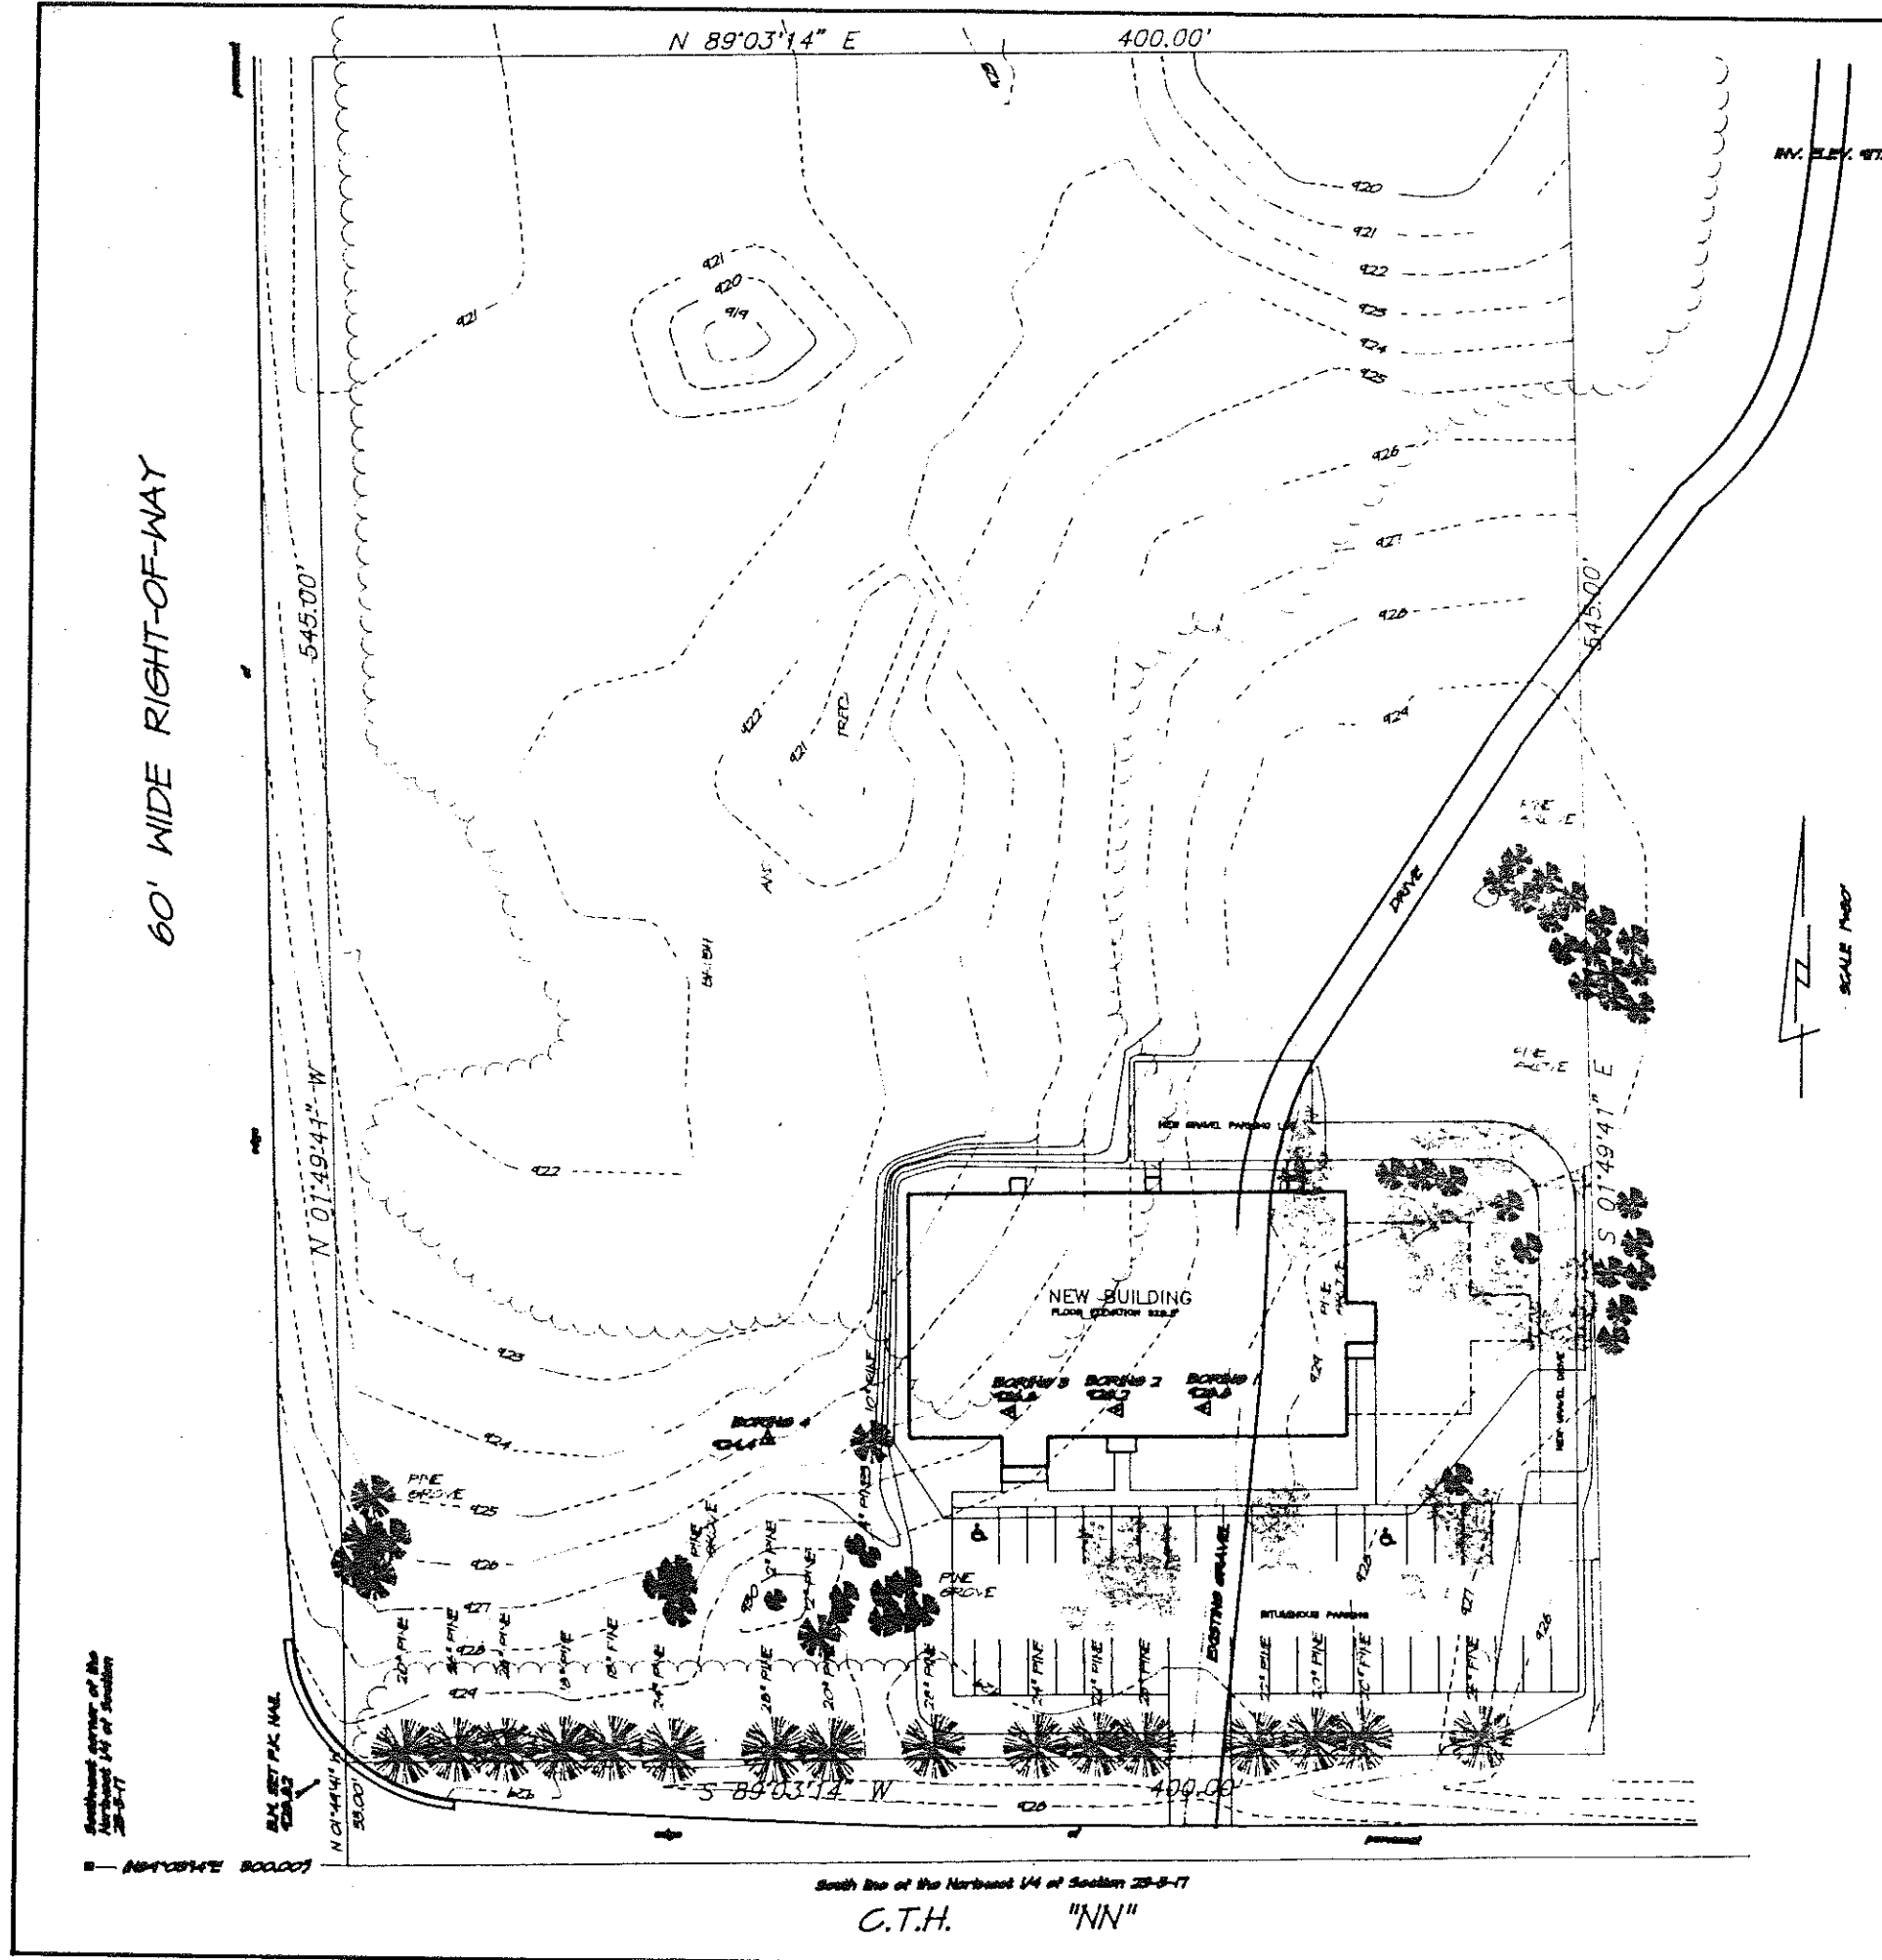


Southwest Corner of the Northeast 1/4 of Section 28-8-17

South End of the Northeast 1/4 of Section 28-8-17

C.T.H. "NN"

<p>CENTRAL ENGINEERS & ARCHITECTS, INC. 810 Grove Street P.O. Box 337 Beaver Dam, WI 53004 (614) 887-3127 FAX (614) 887-7898</p>	SITE PLAN AND SHEET INDEX		
	JOINT MUNICIPAL BUILDING VILLAGE OF EAGLE TOWN OF EAGLE EAGLE, WISCONSIN		
	DRAWN BY: RIV	DATE: JANUARY 11, 1994	SHEET: 6001
	APPROVED:	SCALE: 1" = 30'-0"	JOB NO. 8400

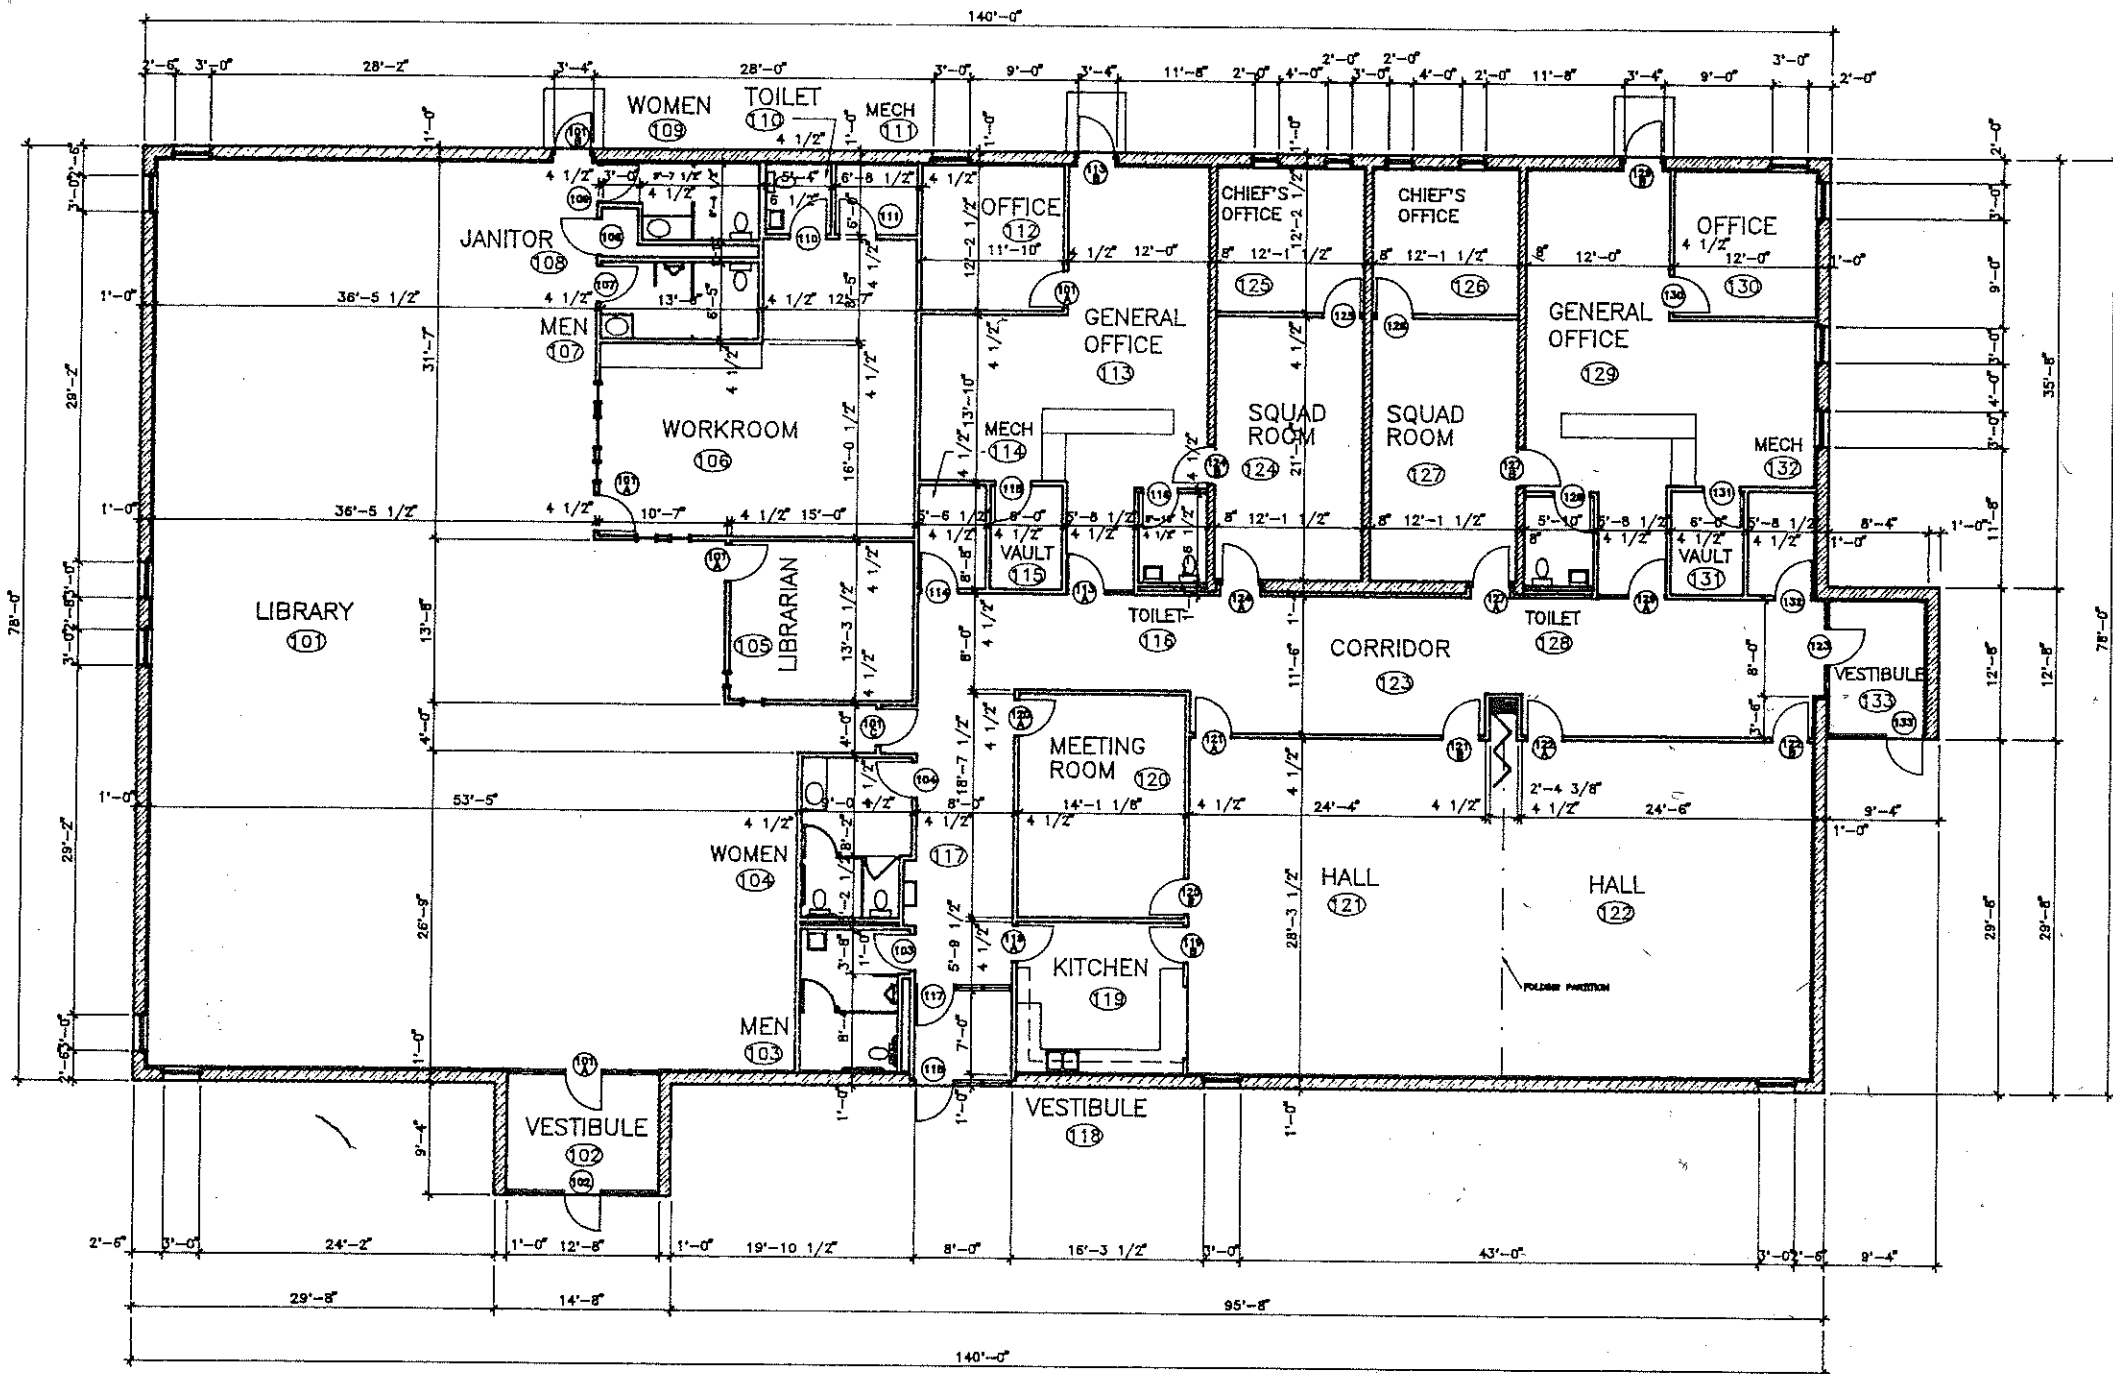


FLOOR PLAN 1/8" = 1'-0"



140
78
1120
180
10920 sq ft
+624 sq ft in Library

DOOR SCHEDULE


DOOR NUMBER	DOOR SIZE	DOOR			FRAME			REMARKS
		MATERIAL	TYPE	HARDWARE	FINISH	MATERIAL	TYPE	
101A	3'-0" X 7'-0"	METAL	C		PNT ALUM	SPL	AL	
101B	3'-0" X 7'-0"	METAL	C		PTD ALUM	SPL	AL	
101C	3'-0" X 7'-0"	WOOD	A		S&V WOOD	A	S&V	
102	3'-0" X 7'-0"	METAL	C		PNT ALUM	SPL	AL	
103	3'-0" X 7'-0"	WOOD	A		S&V WOOD	A	S&V	SIGN - MEN, INT'L HC
104	3'-0" X 7'-0"	WOOD	A		S&V WOOD	A	S&V	SIGN - WOMEN, INT'L HC
105	3'-0" X 7'-0"	WOOD	A		S&V WOOD	A	S&V	
106	3'-0" X 7'-0"	WOOD	A		S&V WOOD	A	S&V	
107	3'-0" X 7'-0"	WOOD	A		S&V WOOD	A	S&V	SIGN - MEN, INT'L HC
108	3'-0" X 7'-0"	WOOD	A		S&V WOOD	A	S&V	
109	3'-0" X 7'-0"	WOOD	A		S&V WOOD	A	S&V	SIGN - WOMEN, INT'L HC
110	3'-0" X 7'-0"	WOOD	A		S&V WOOD	A	S&V	SIGN - TOILET
111	3'-0" X 7'-0"	WOOD	A		S&V WOOD	A	S&V	
112	3'-0" X 7'-0"	WOOD	A		S&V WOOD	A	S&V	
113A	3'-0" X 7'-0"	ALUM	B		AL ALUM	SPL	AL	
113B	3'-0" X 7'-0"	METAL	C		PNT MTL	SPL	PNT	
114	3'-0" X 7'-0"	WOOD	A		S&V WOOD	A	S&V	
115	3'-0" X 7'-0"	METAL	A		PNT MTL	B	PNT	2 HR FIRE RATED
116	3'-0" X 7'-0"	WOOD	A		S&V WOOD	A	S&V	SIGN - TOILET
117	3'-0" X 7'-0"	METAL	C		PNT ALUM	SPL	AL	
118	3'-0" X 7'-0"	METAL	C		PTD ALUM	SPL	AL	
118A	3'-0" X 7'-0"	WOOD	A		S&V WOOD	A	S&V	
118B	3'-0" X 7'-0"	WOOD	A		S&V WOOD	A	S&V	
120A	3'-0" X 7'-0"	WOOD	A		S&V WOOD	A	S&V	
120B	3'-0" X 7'-0"	WOOD	A		S&V WOOD	A	S&V	
121A	3'-0" X 7'-0"	WOOD	A		S&V WOOD	A	S&V	
121B	3'-0" X 7'-0"	WOOD	A		S&V WOOD	A	S&V	
122A	3'-0" X 7'-0"	WOOD	A		S&V WOOD	A	S&V	
122B	3'-0" X 7'-0"	WOOD	A		S&V WOOD	A	S&V	
123	3'-0" X 7'-0"	METAL	C		PNT ALUM	SPL	AL	
124A	3'-0" X 7'-0"	METAL	A		PNT MTL	B	PNT	2 HR FIRE RATED
124B	3'-0" X 7'-0"	METAL	A		PNT MTL	B	PNT	2 HR FIRE RATED
125	3'-0" X 7'-0"	WOOD	A		S&V WOOD	A	S&V	
126	3'-0" X 7'-0"	WOOD	A		S&V WOOD	A	S&V	
127A	3'-0" X 7'-0"	METAL	A		PNT MTL	B	PNT	2 HR FIRE RATED
127B	3'-0" X 7'-0"	METAL	A		PNT MTL	B	PNT	2 HR FIRE RATED
128	3'-0" X 7'-0"	WOOD	A		S&V WOOD	A	S&V	SIGN - TOILET
129A	3'-0" X 7'-0"	ALUM	B		AL ALUM	SPL	AL	
129B	3'-0" X 7'-0"	METAL	C		PNT MTL	SPL	PNT	
130	3'-0" X 7'-0"	WOOD	A		S&V WOOD	A	S&V	
131	3'-0" X 7'-0"	METAL	A		PTD METAL	B	PTD	2 HOUR FIRE RATED
132	3'-0" X 7'-0"	WOOD	A		S&V WOOD	A	S&V	
133	3'-0" X 7'-0"	METAL	C		PTD ALUM	SPL	AL	

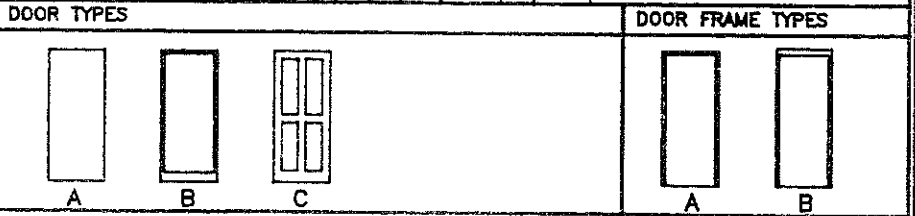

CENTRAL
ENGINEERS & ARCHITECTS, INC.
810 Grove Street
P.O. Box 337
Beaver Dam, WI 53018
(414) 887-3127
FAX (414) 887-7908

FLOOR PLAN
JOINT MUNICIPAL BUILDING
VILLAGE OF EAGLE
TOWN OF EAGLE
EAGLE, WISCONSIN

DRAWN BY: RIV	DATE: JANUARY 11, 1995	SHEET: A101
APPROVED:	SCALE: 1/8" = 1'-0"	JOB NO. 8400

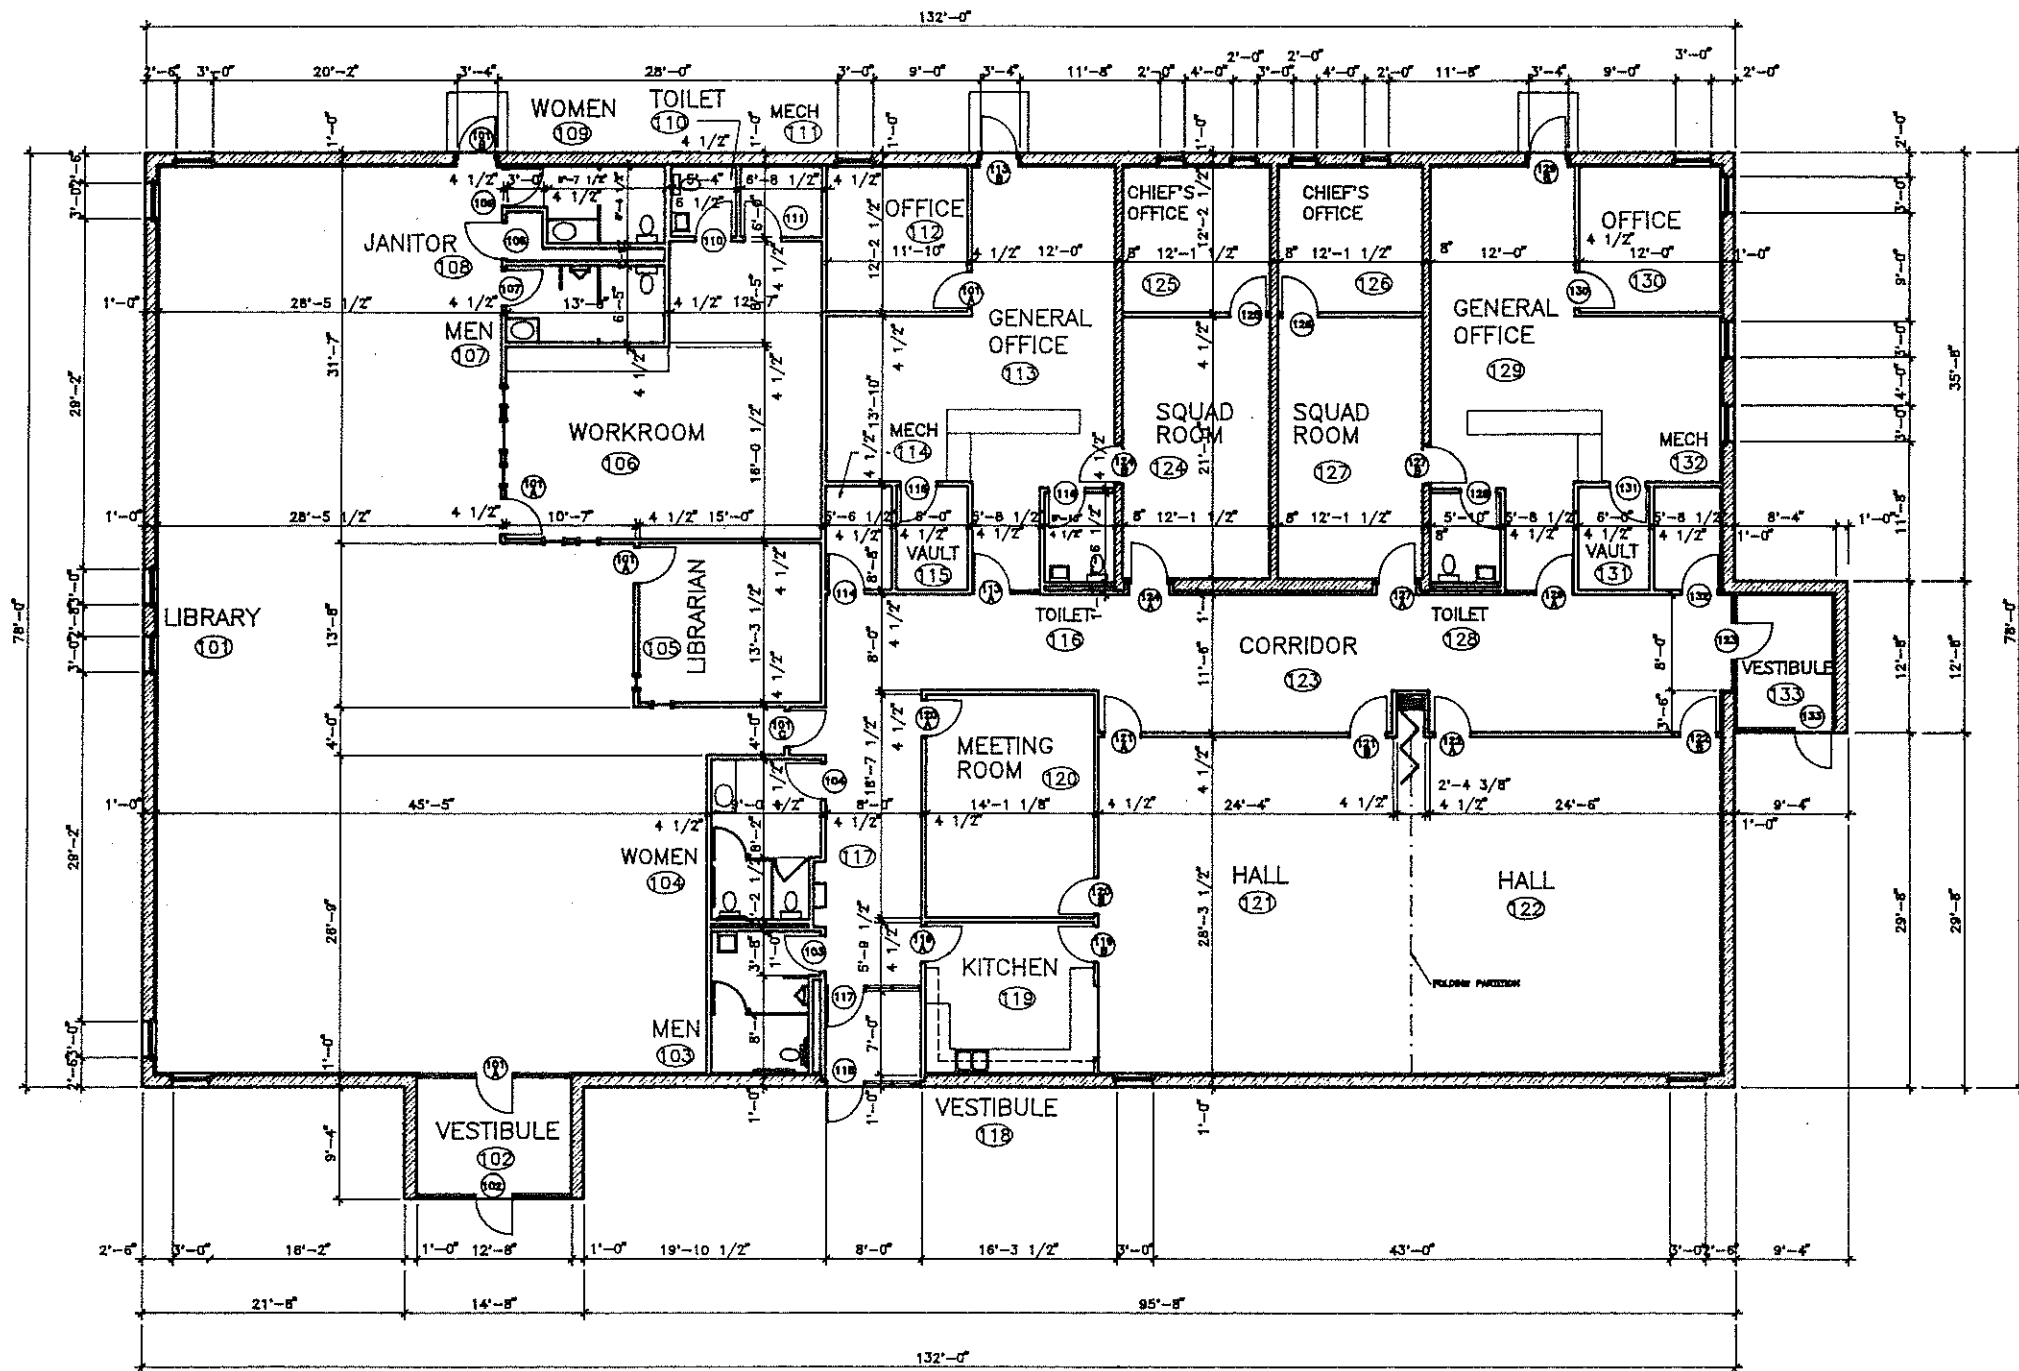


ALTERNATE FLOOR PLAN 1/8" = 1'-0"




132
78
1056
924
10,296


<p>CENTRAL ENGINEERS & ARCHITECTS, INC. 810 Grove Street P.O. Box 337 Beaver Dam, WI 53016 (414) 887-3127 FAX (414) 887-7898</p>	ALTERNATE FLOOR PLAN		
	JOINT MUNICIPAL BUILDING VILLAGE OF EAGLE TOWN OF EAGLE EAGLE, WISCONSIN		
	DRAWN BY: RIV	DATE: JANUARY 11, 1998	SHEET
	APPROVED:	SCALE: 1/8" = 1'-0"	JOB NO. 8400
			A102

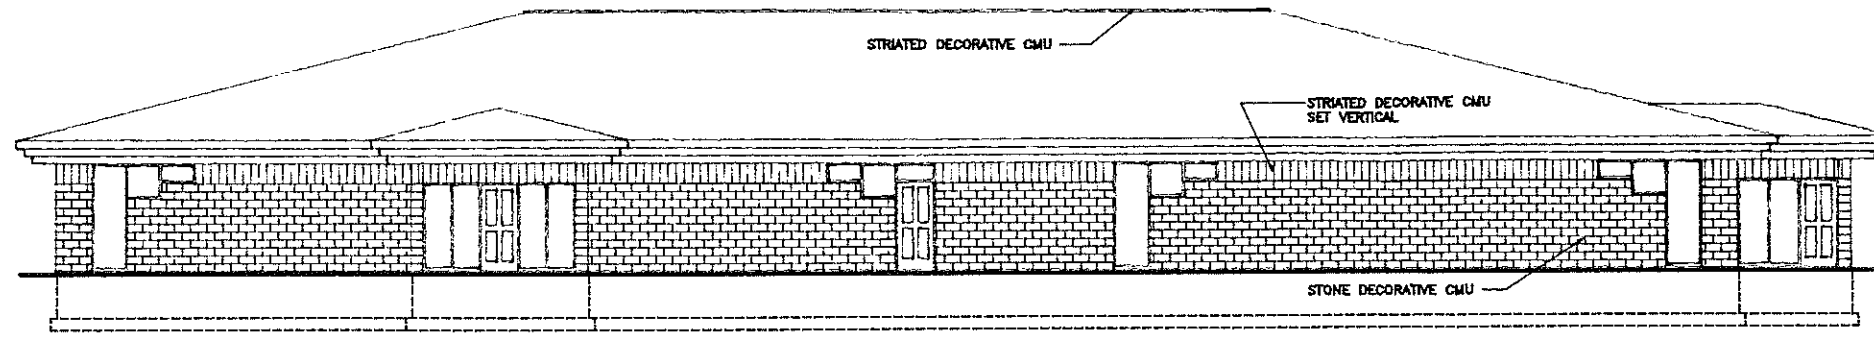


SOUTH ELEVATION
1/8" = 1'-0"

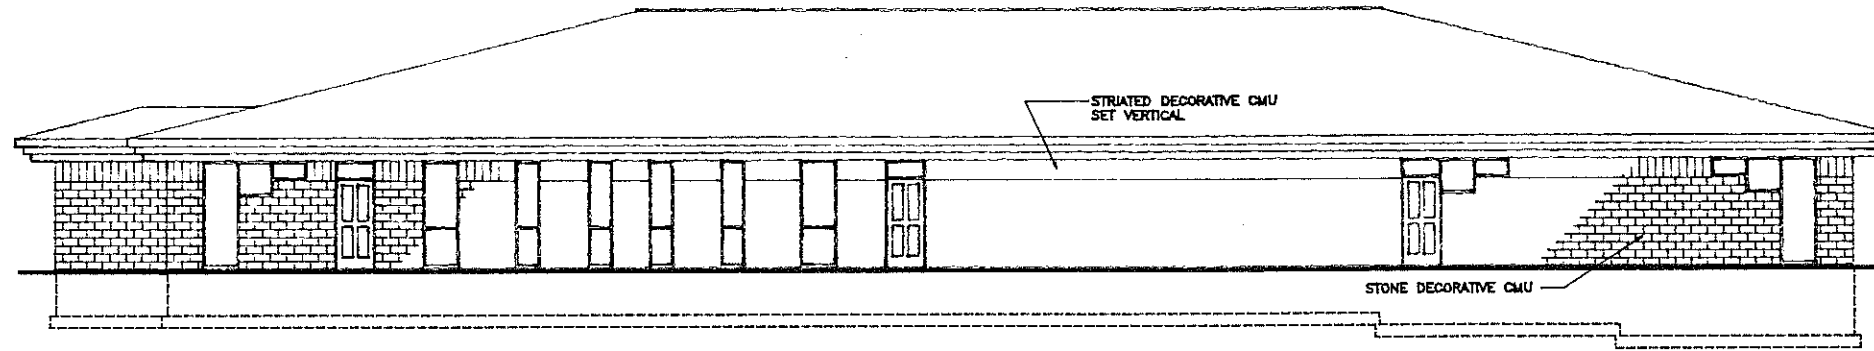


NORTH ELEVATION
1/8" = 1'-0"

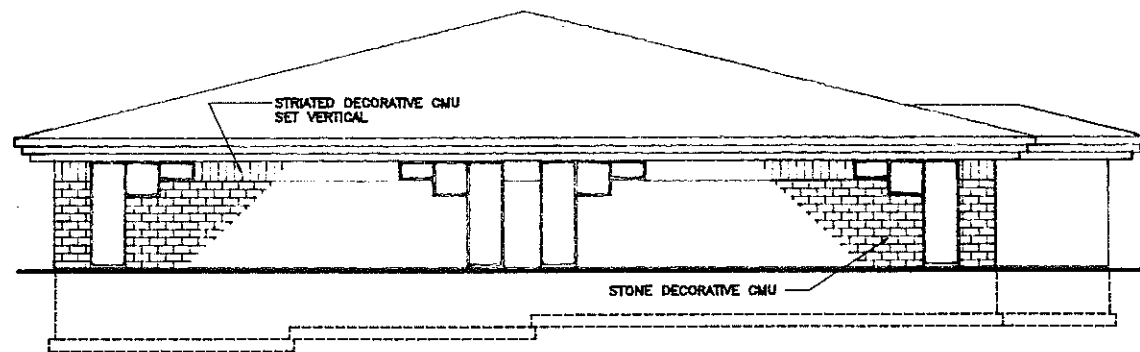

WEST ELEVATION
1/8" = 1'-0"

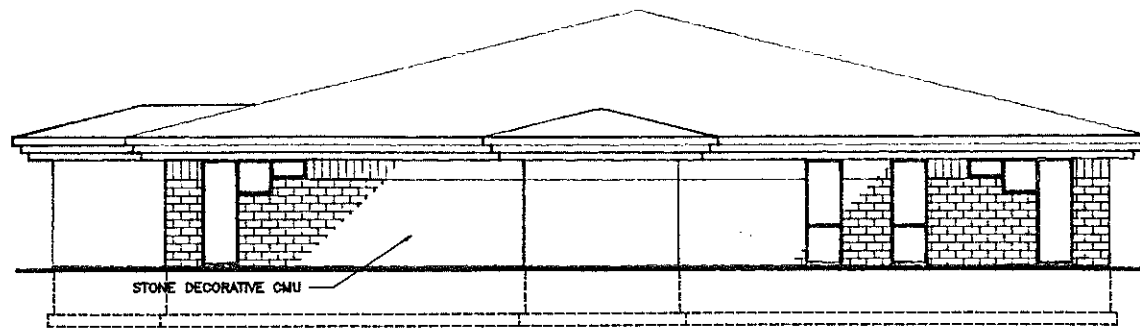


EAST ELEVATION
1/8" = 1'-0"

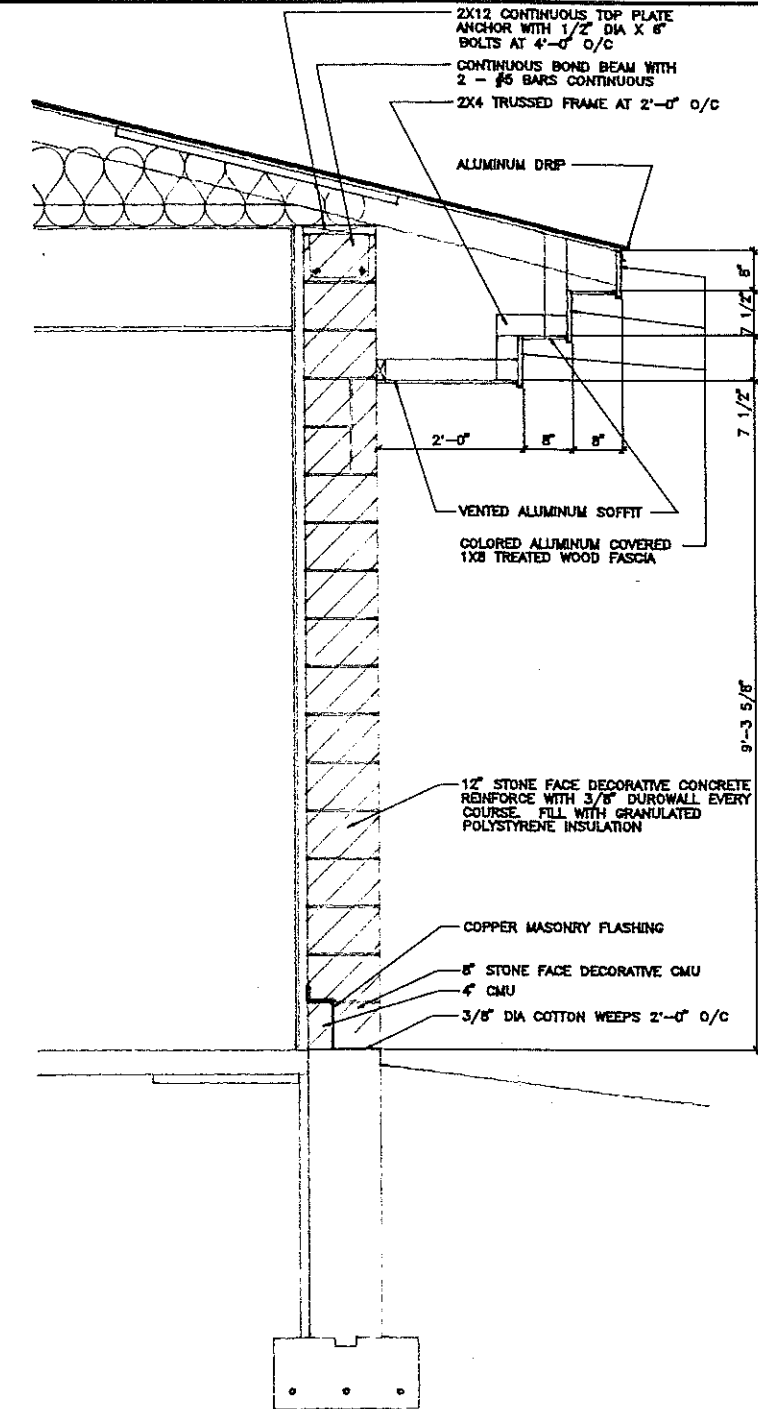


SECTION 1
3/8" = 1'-0" (A201)


<p>CENTRAL ENGINEERS & ARCHITECTS, INC. 605 Green Street P.O. Box 257 Eagle, Wis. 53122 (414) 887-2227 FAX (414) 887-2228</p>	ELEVATIONS		
	JOINT MUNICIPAL BUILDING VILLAGE OF EAGLE TOWN OF EAGLE EAGLE, WISCONSIN		
	DESIGNED BY BRAND STUBBINS RIV APPROVED	DATE JANUARY 11, 1994	SHEET A201
	SCALE 1/8" = 1'-0"	JOB NO. 8400	

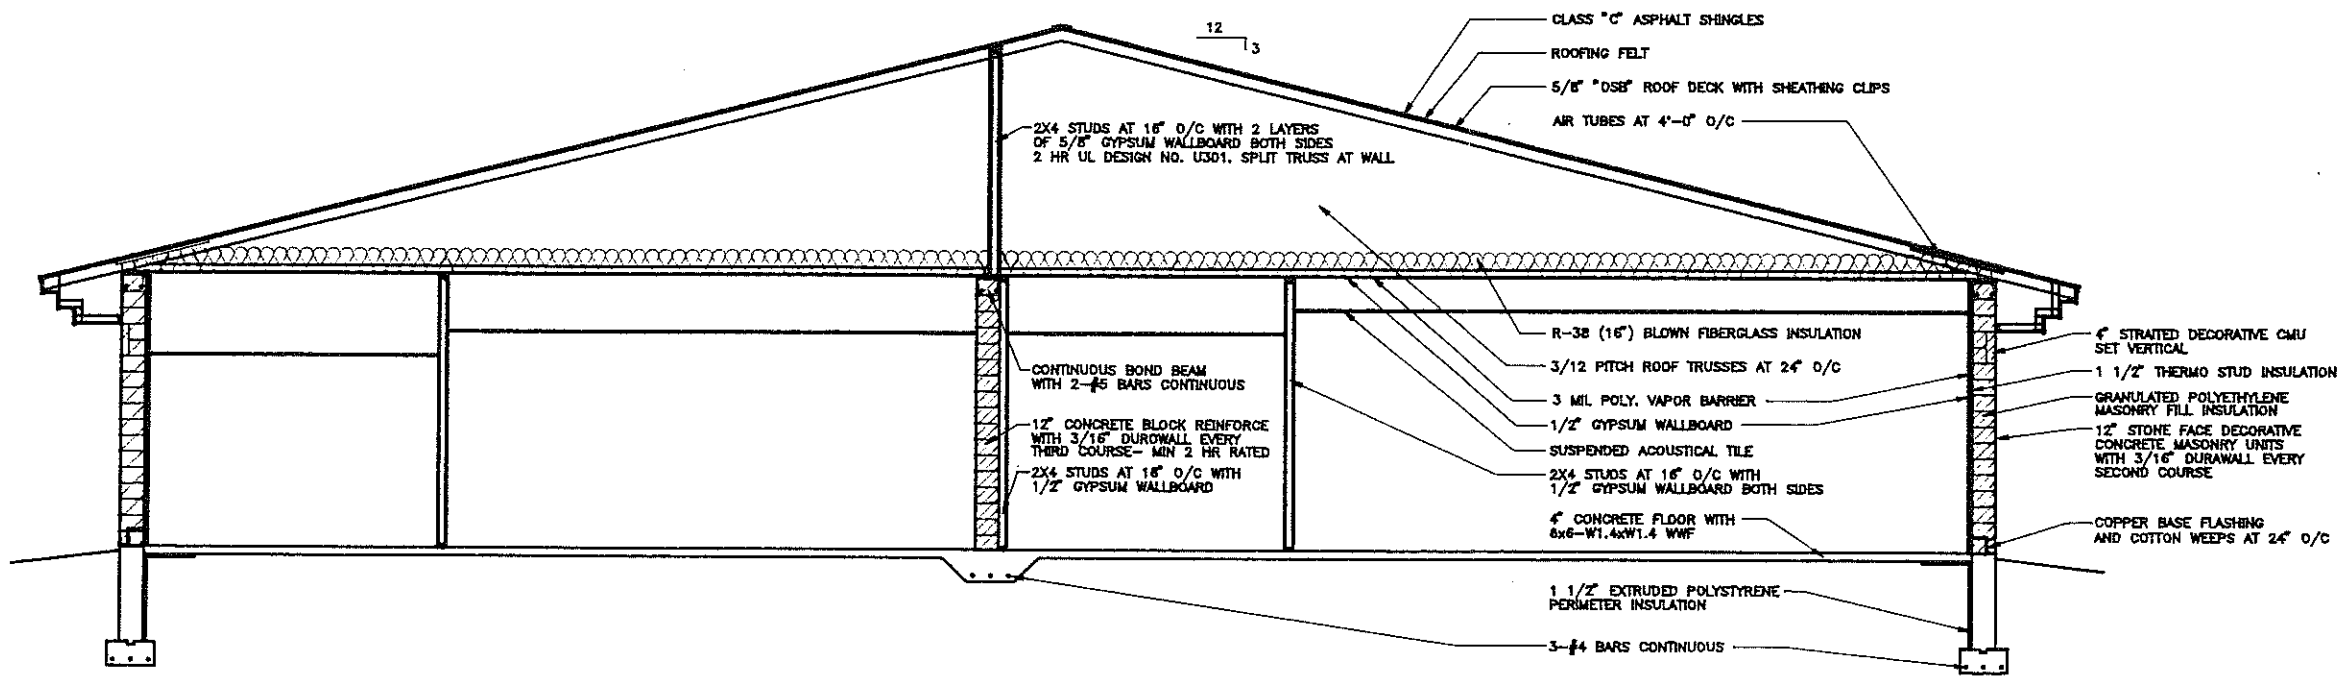


SECTION 2
1/4" = 1'-0" A202

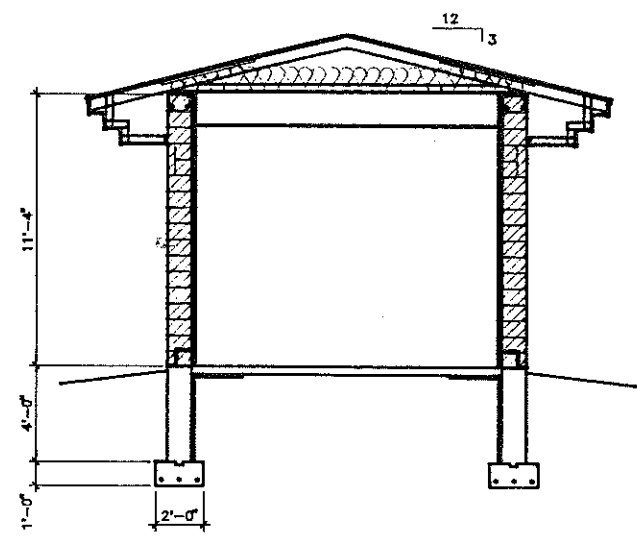

SECTION 1
1/4" = 1'-0" A202

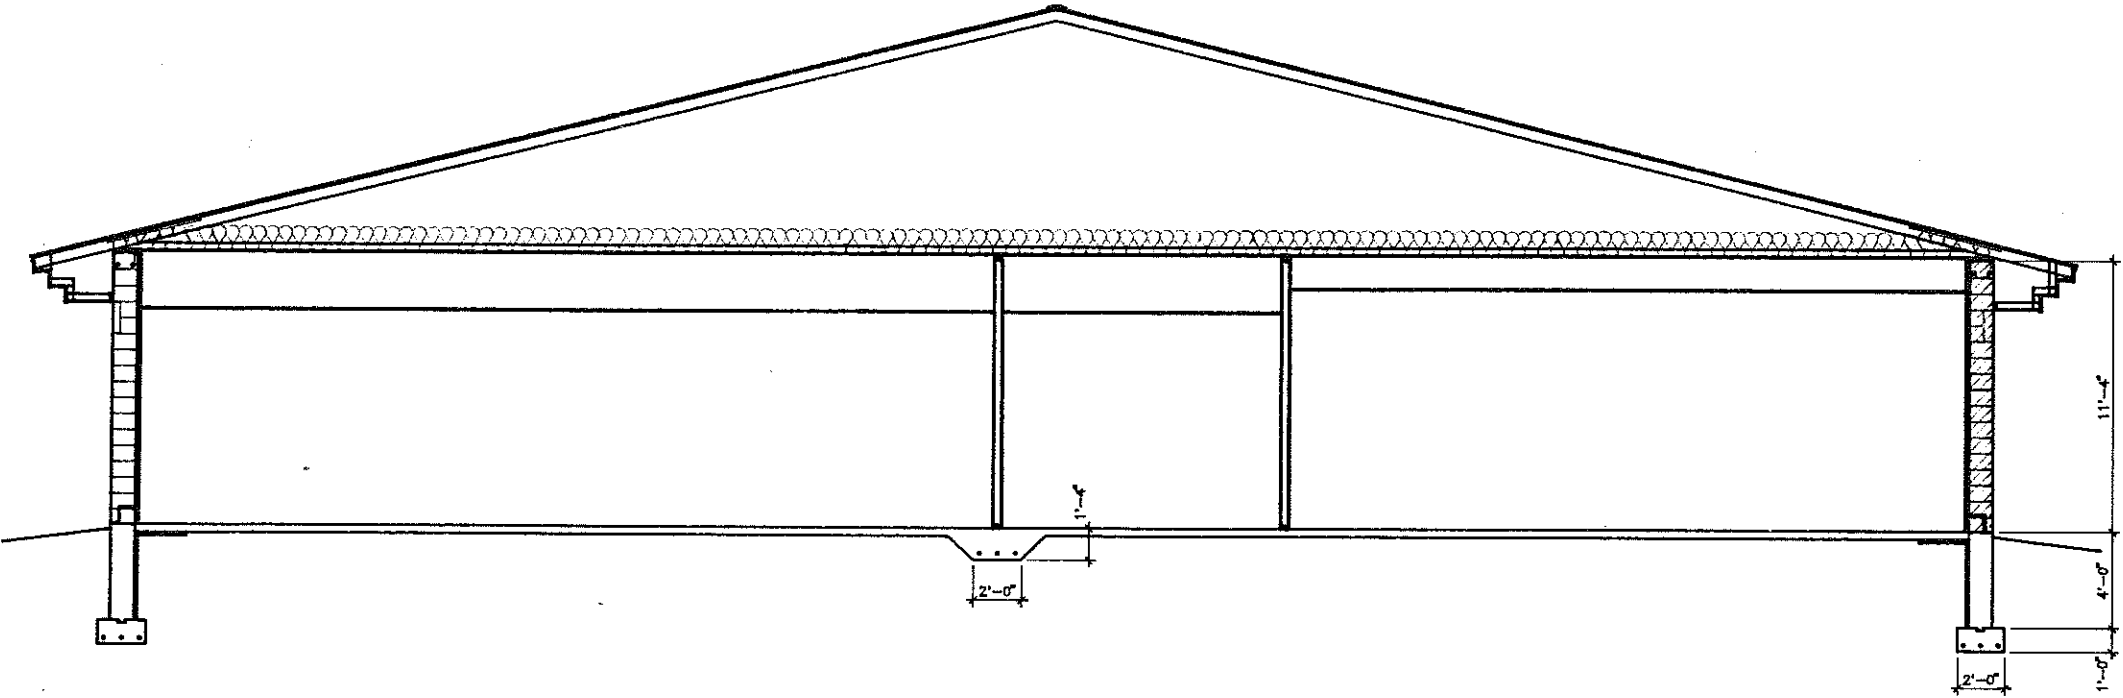


SECTION 4
1/4" = 1'-0" A202


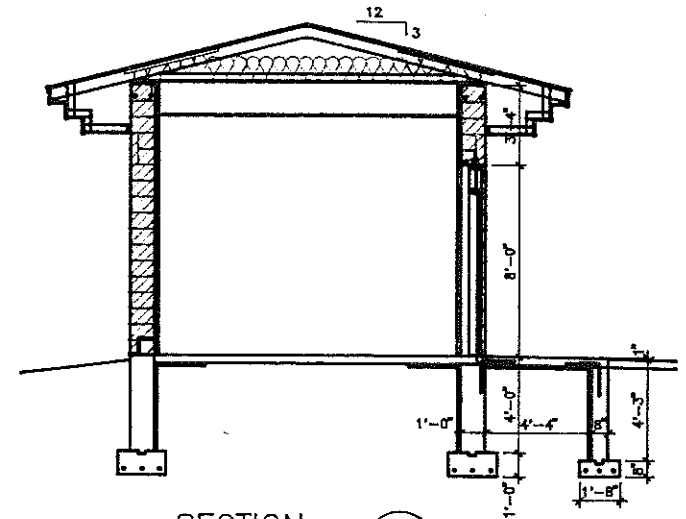


SECTION 3
1/4" = 1'-0" A202


<p>CENTRAL ENGINEERS & ARCHITECTS, INC. 600 State Street P.O. Box 257 Eagle, Wis. 53122 (414) 885-2200 FAX (414) 885-2205</p>	CROSS SECTIONS		
	JOINT MUNICIPAL BUILDING VILLAGE OF EAGLE TOWN OF EAGLE EAGLE, WISCONSIN		
	DESIGNED BY BRANDT RIV	DATE JANUARY 11, 1994	SHEET
	APPROVED	JOB NO. 8400	A202

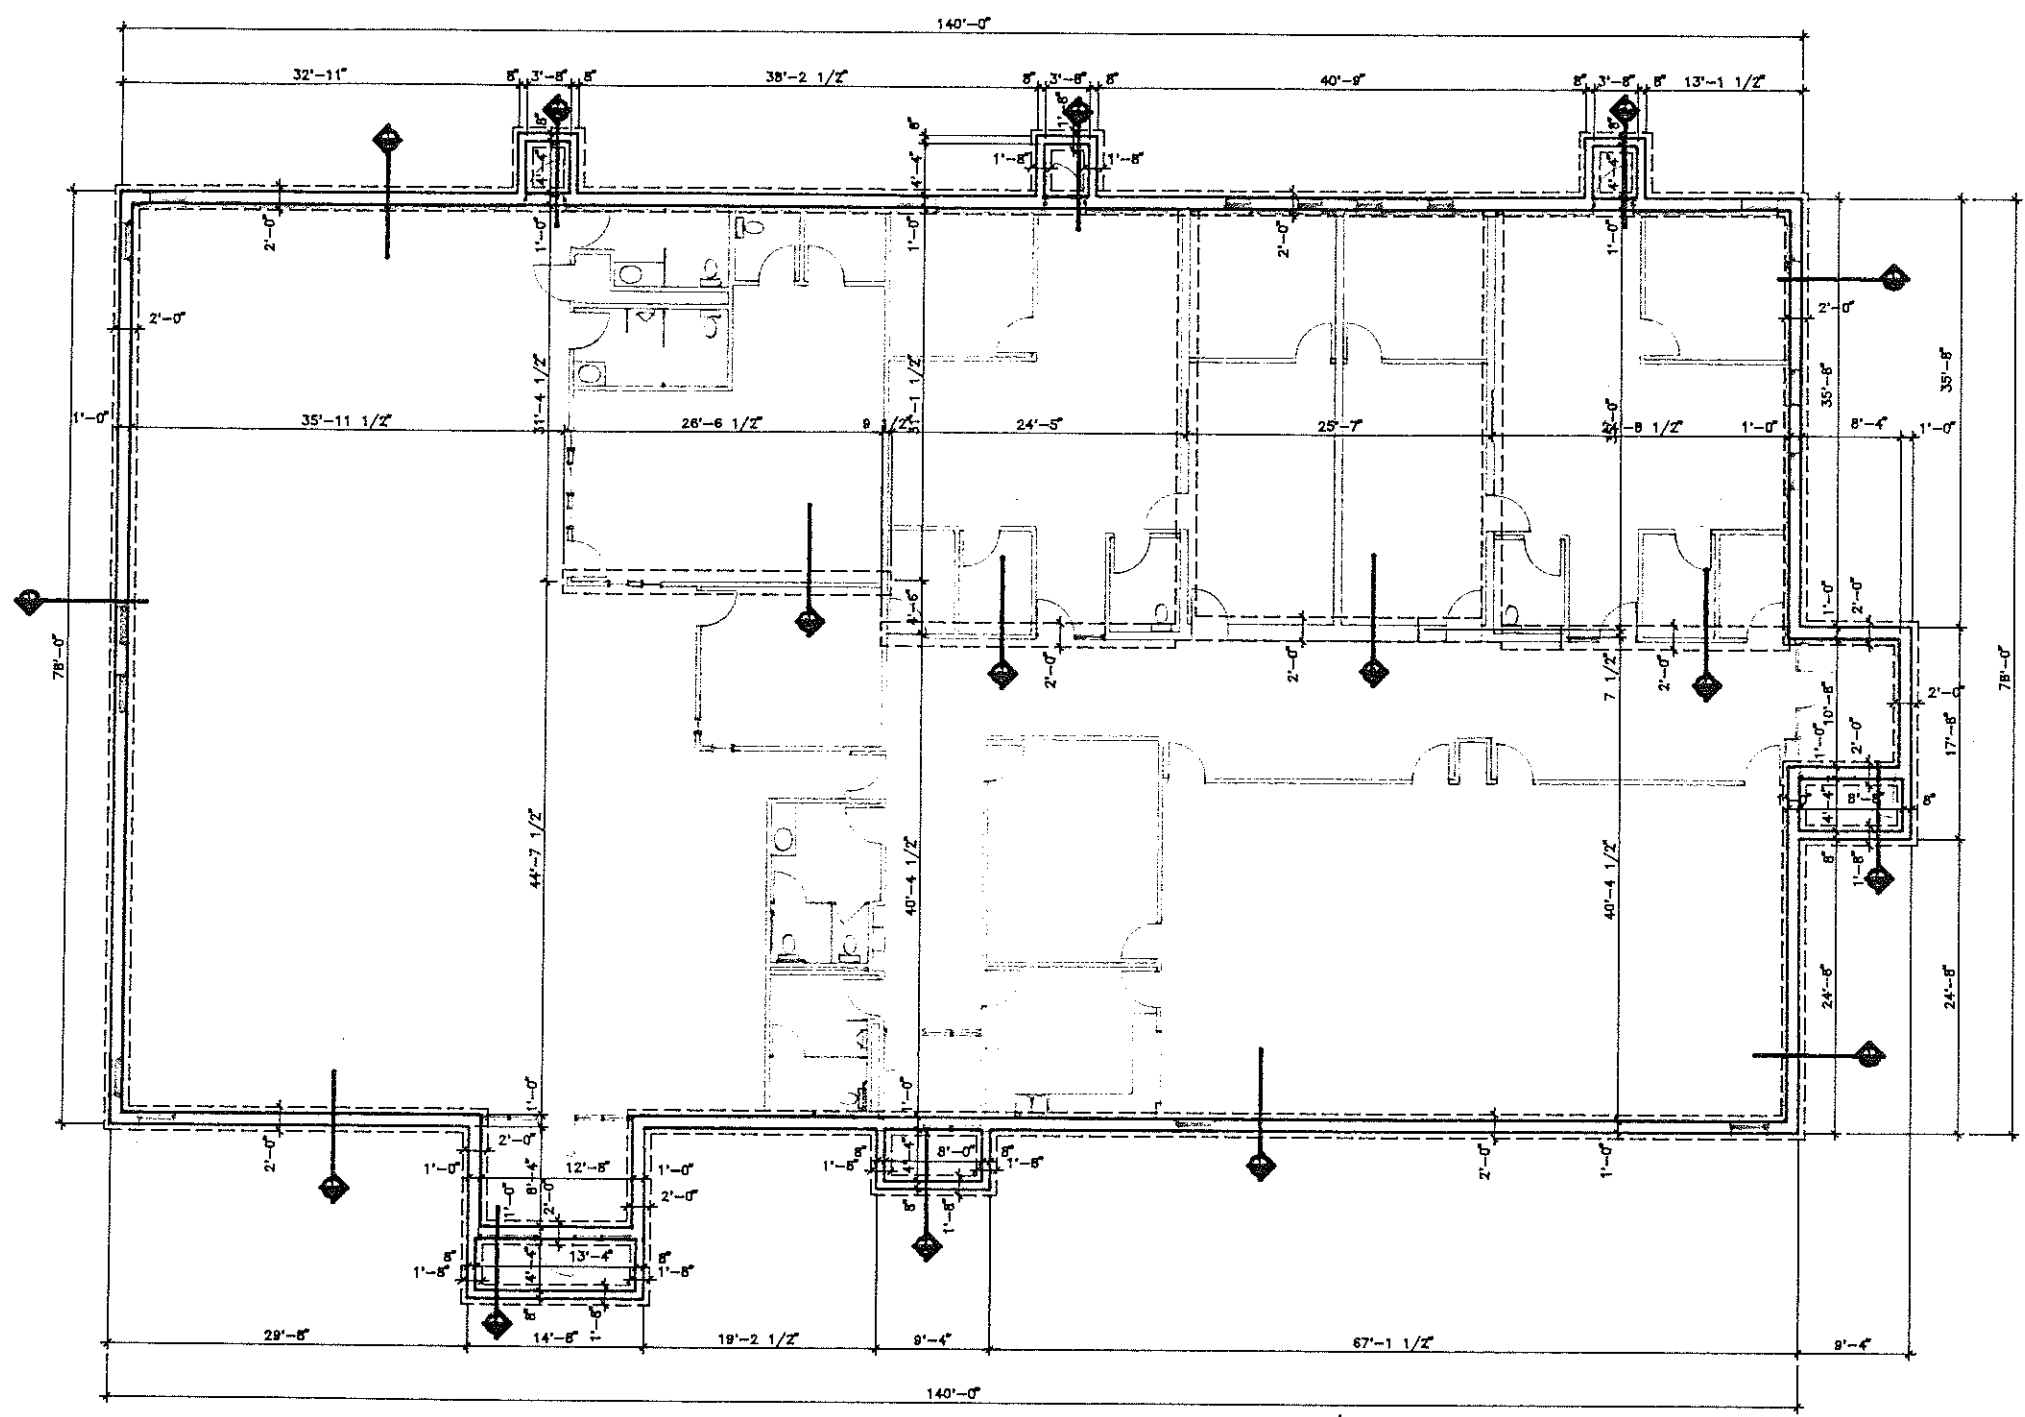


FOUNDATION PLAN 1/8" = 1'-0"

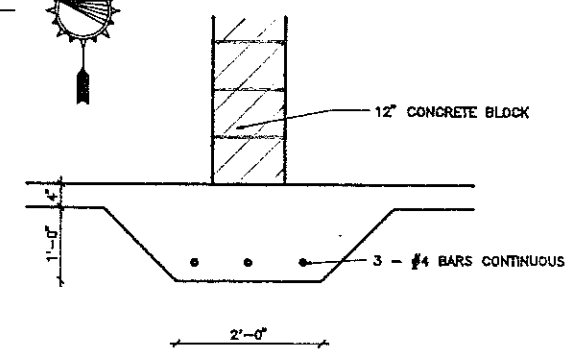 


SECTION 1
3/8" = 1'-0" (S10)

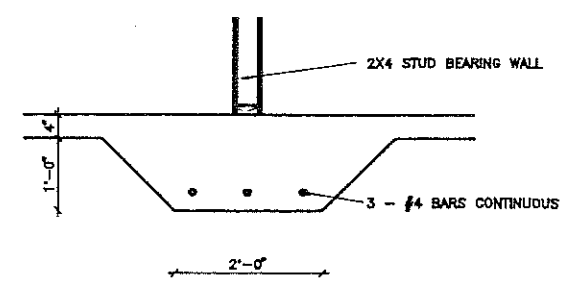

SECTION 2
3/8" = 1'-0" (S10)

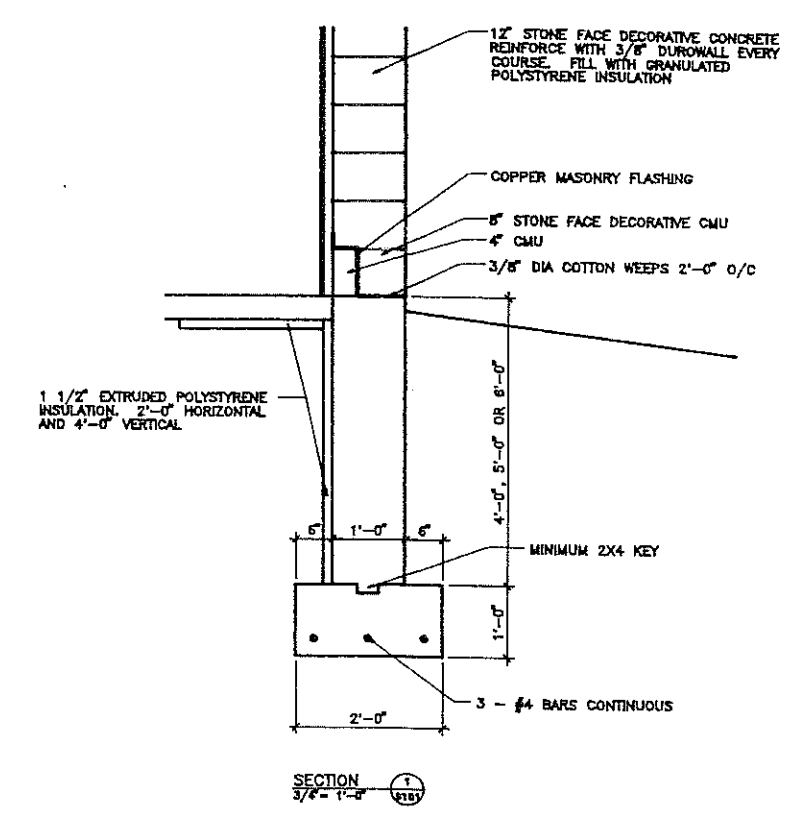

SECTION 3
3/8" = 1'-0" (S10)

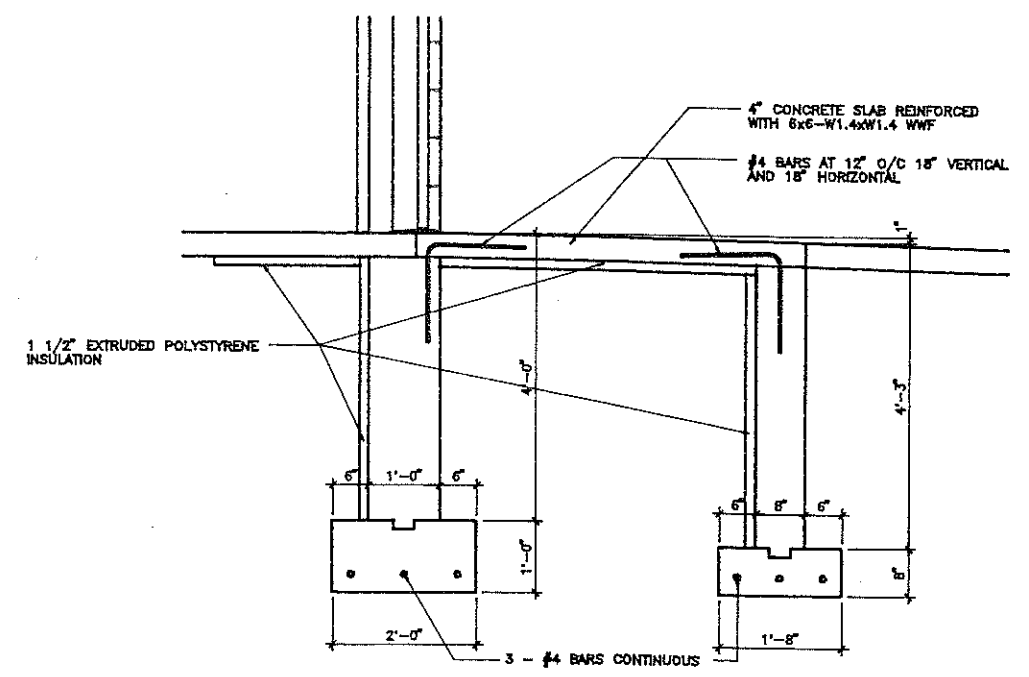

SECTION 4
3/8" = 1'-0" (S10)

CENTRAL
ENGINEERS & ARCHITECTS, INC.
910 Grove Street
P.O. Box 337
Beaver Dam, WI 53016
(414) 887-3127
FAX (414) 887-7998

FOUNDATION PLAN & DETAILS		
JOINT MUNICIPAL BUILDING VILLAGE OF EAGLE TOWN OF EAGLE EAGLE, WISCONSIN		
DRAWN BY: RJV	DATE: DECEMBER 27, 1995	SHEET: 5101
APPROVED:	JOB NO. 8400	
SCALE: 1/8" = 1'-0"		